
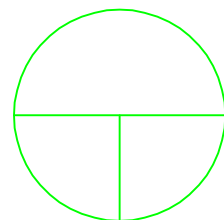


서관 1층 전등 (변경전)

SCALE : 1/300



PROJECT TITLE	
아주대학교	
DRAWING TITLE	
서관 1층 접지평면도	
APPROVAL	PROJECT NO.
CHECK	2006
DRAWING	FILE NAME
C.K. Choi	
SCALE	DRAWING NO.
1/300	EE-01
DATE	2006.10

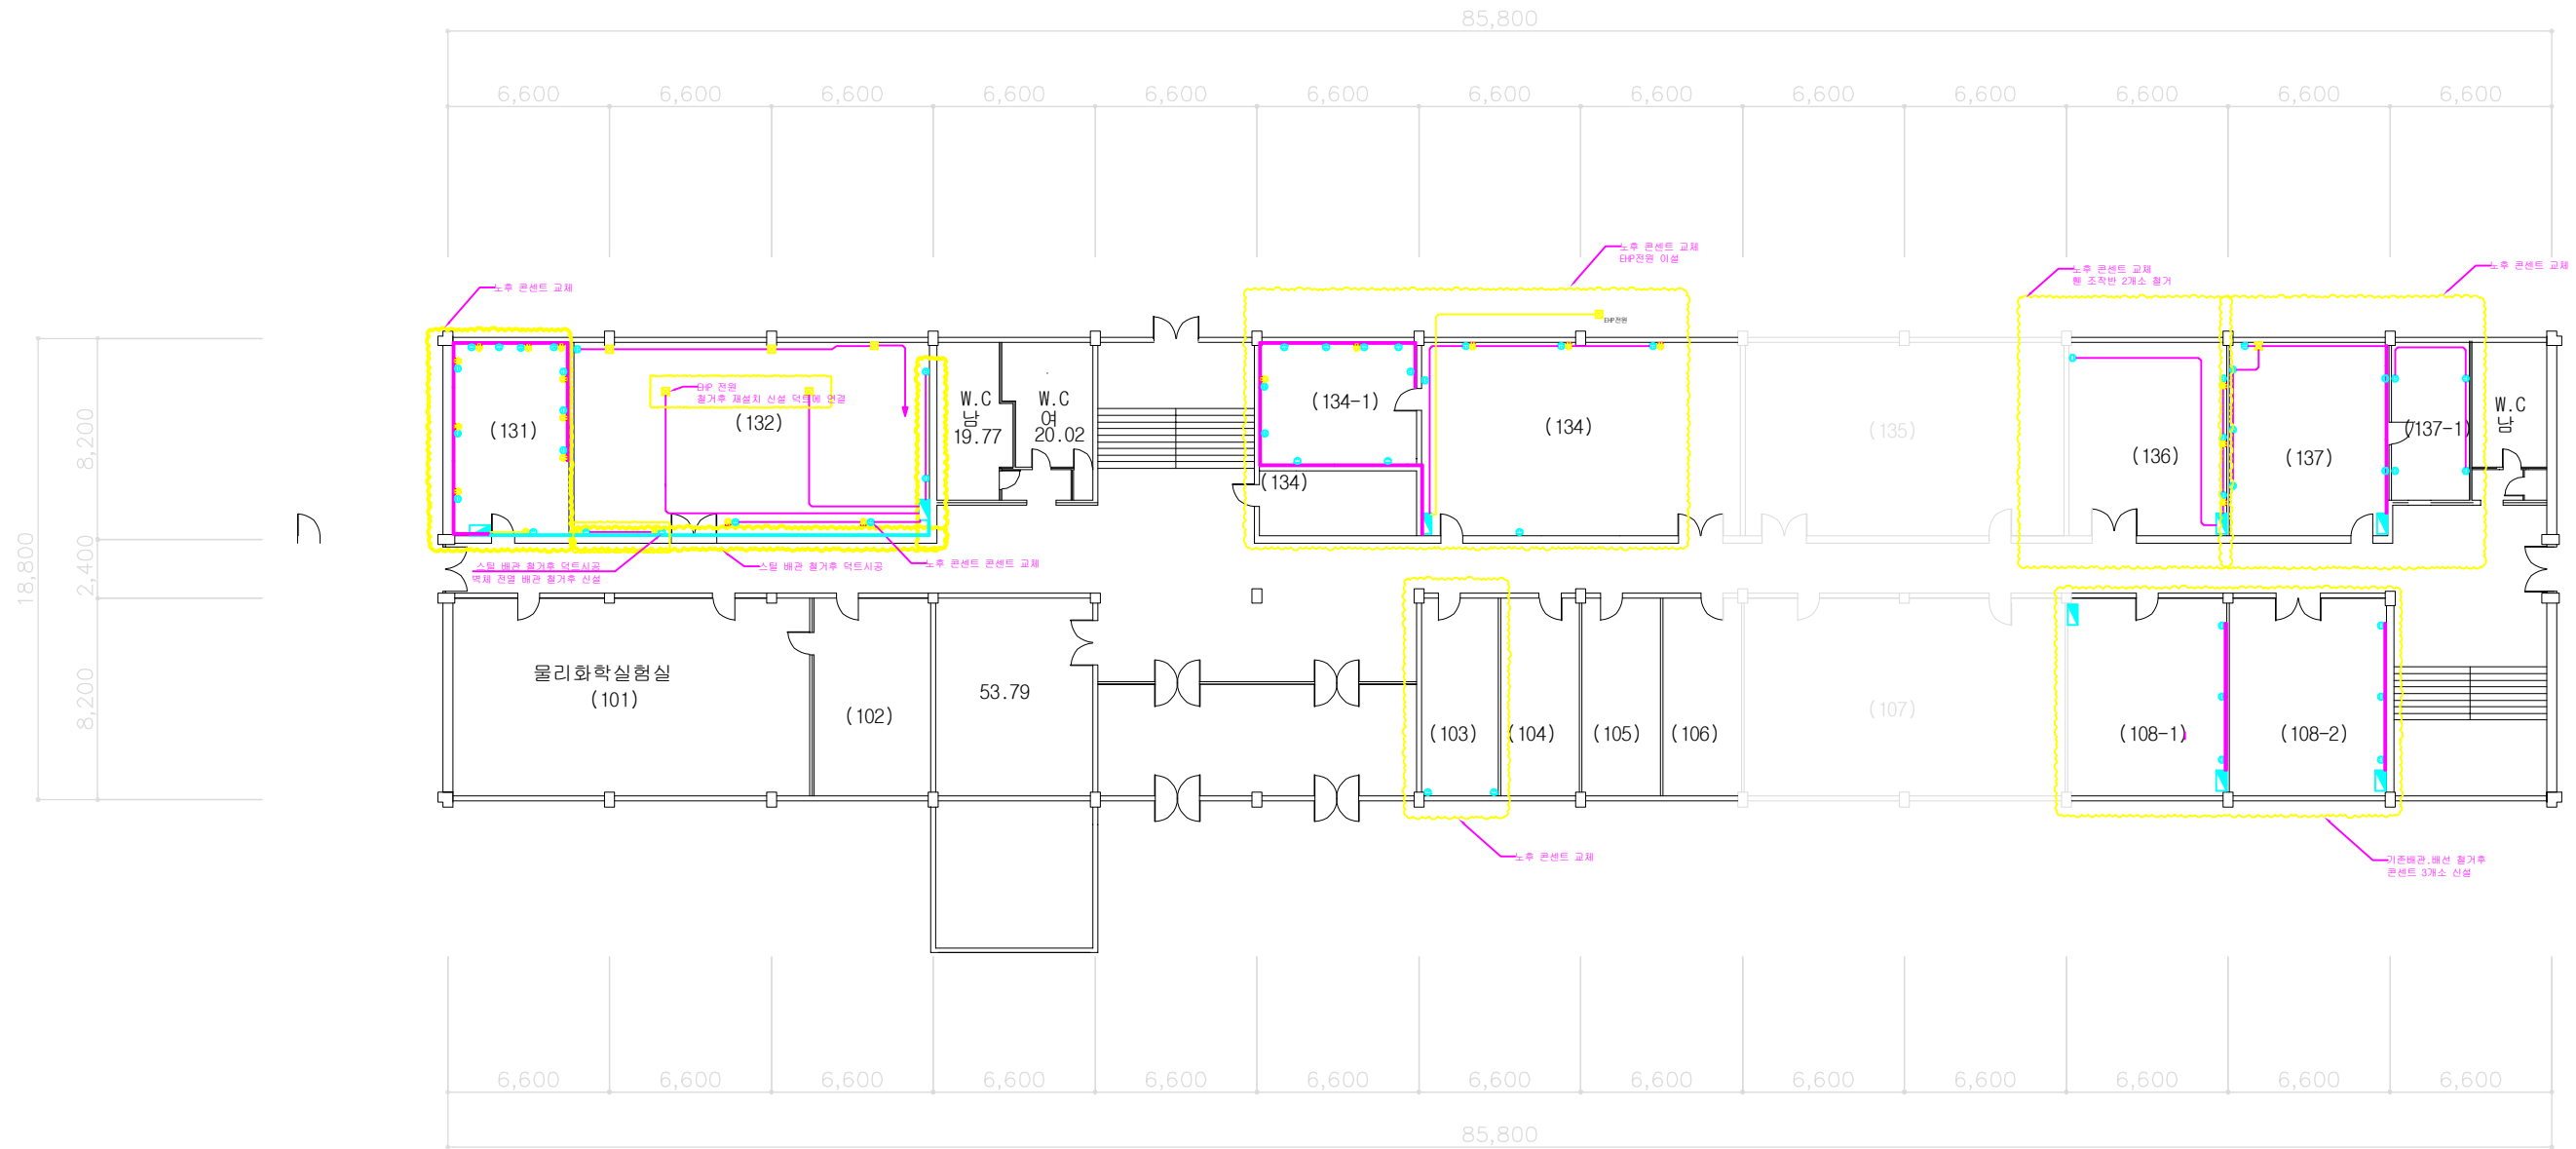

서관 1층 전열 (변경후)

SCALE : 1/300



PROJECT TITLE	
아주대학교	
DRAWING TITLE	
APPROVAL	PROJECT NO.
CHECK	FILE NAME
DRAWING	DRAWING NO.
SCALE	
DATE	

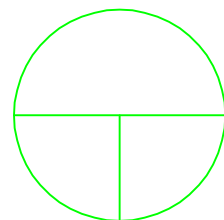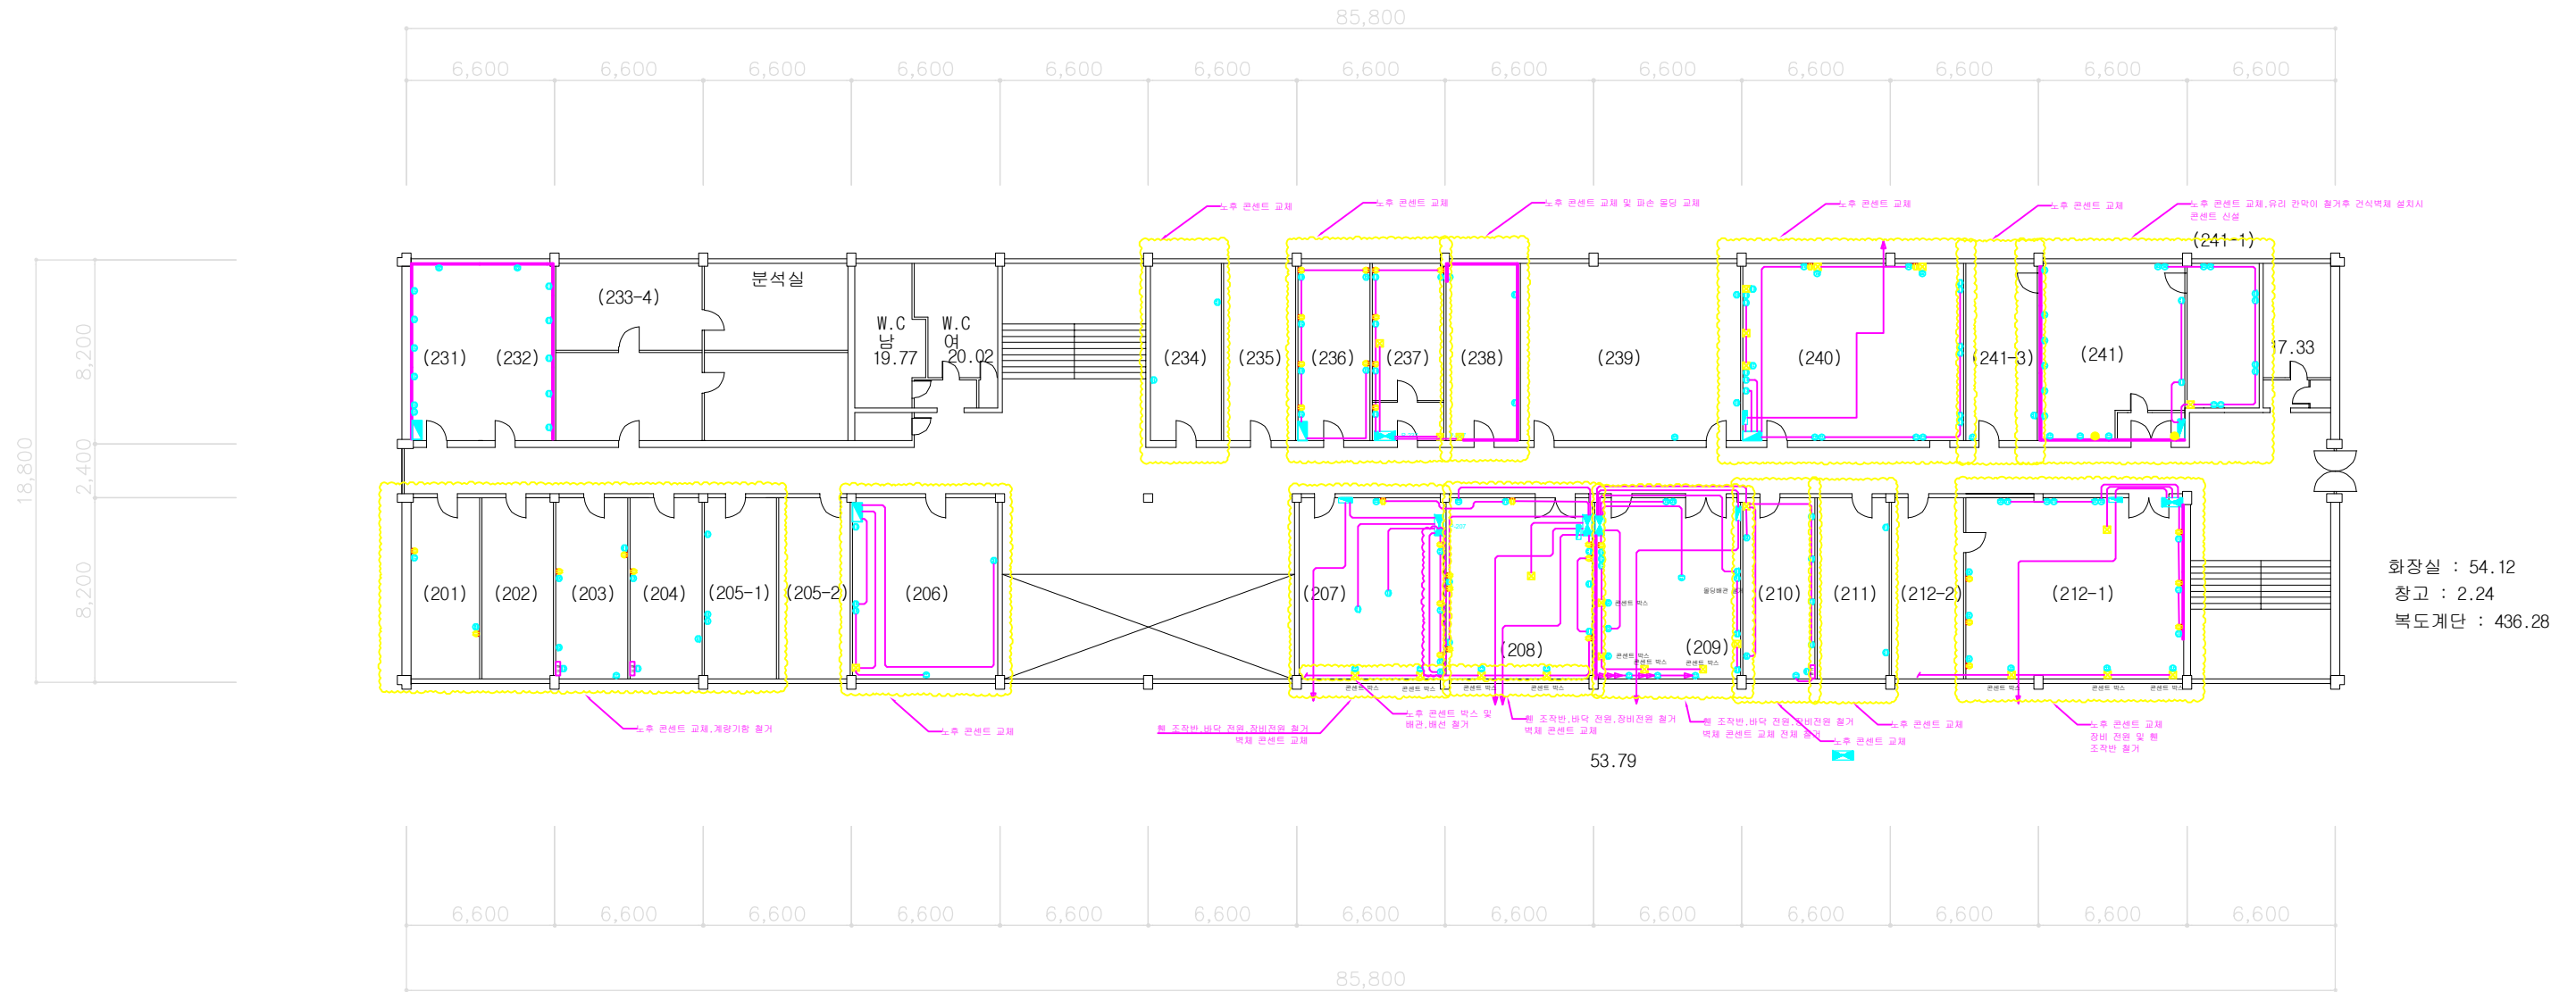

서관 2층 전열 (변경전)

SCALE : 1/300



PROJECT TITLE	
DRAWING TITLE	
APPROVAL	PROJECT NO.
CHECK	FILE NAME
DRAWING	DRAWING NO.
SCALE	
DATE	

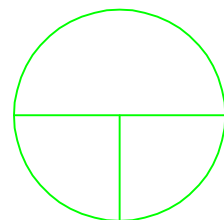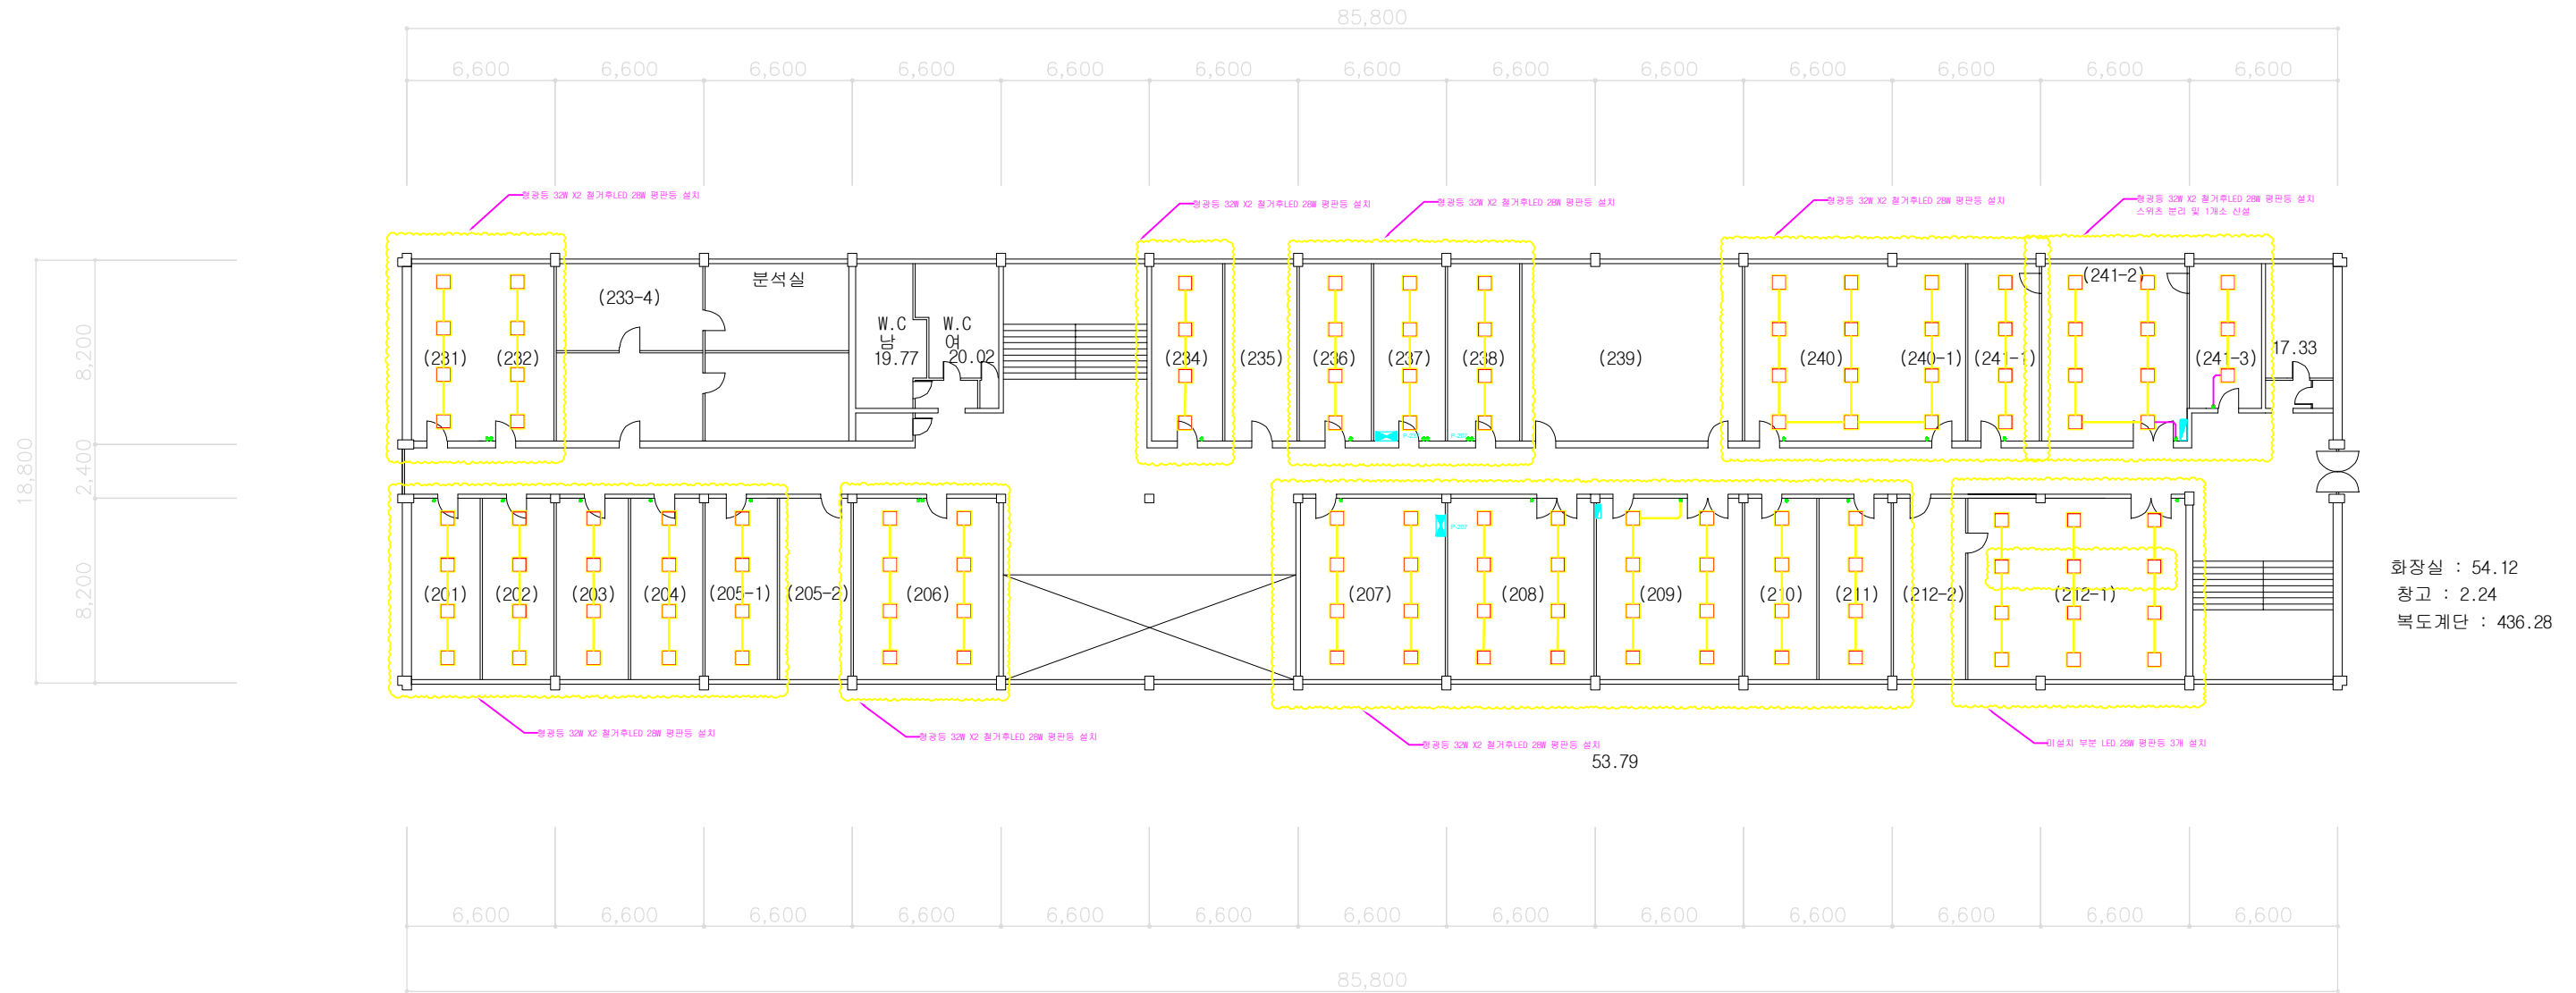

서관 2층 전등 (변경후)

SCALE : 1/300


PROJECT TITLE	
아주대학교	
DRAWING TITLE	
APPROVAL	PROJECT NO.
CHECK	FILE NAME
DRAWING	
SCALE	DRAWING NO.
DATE	

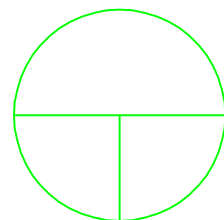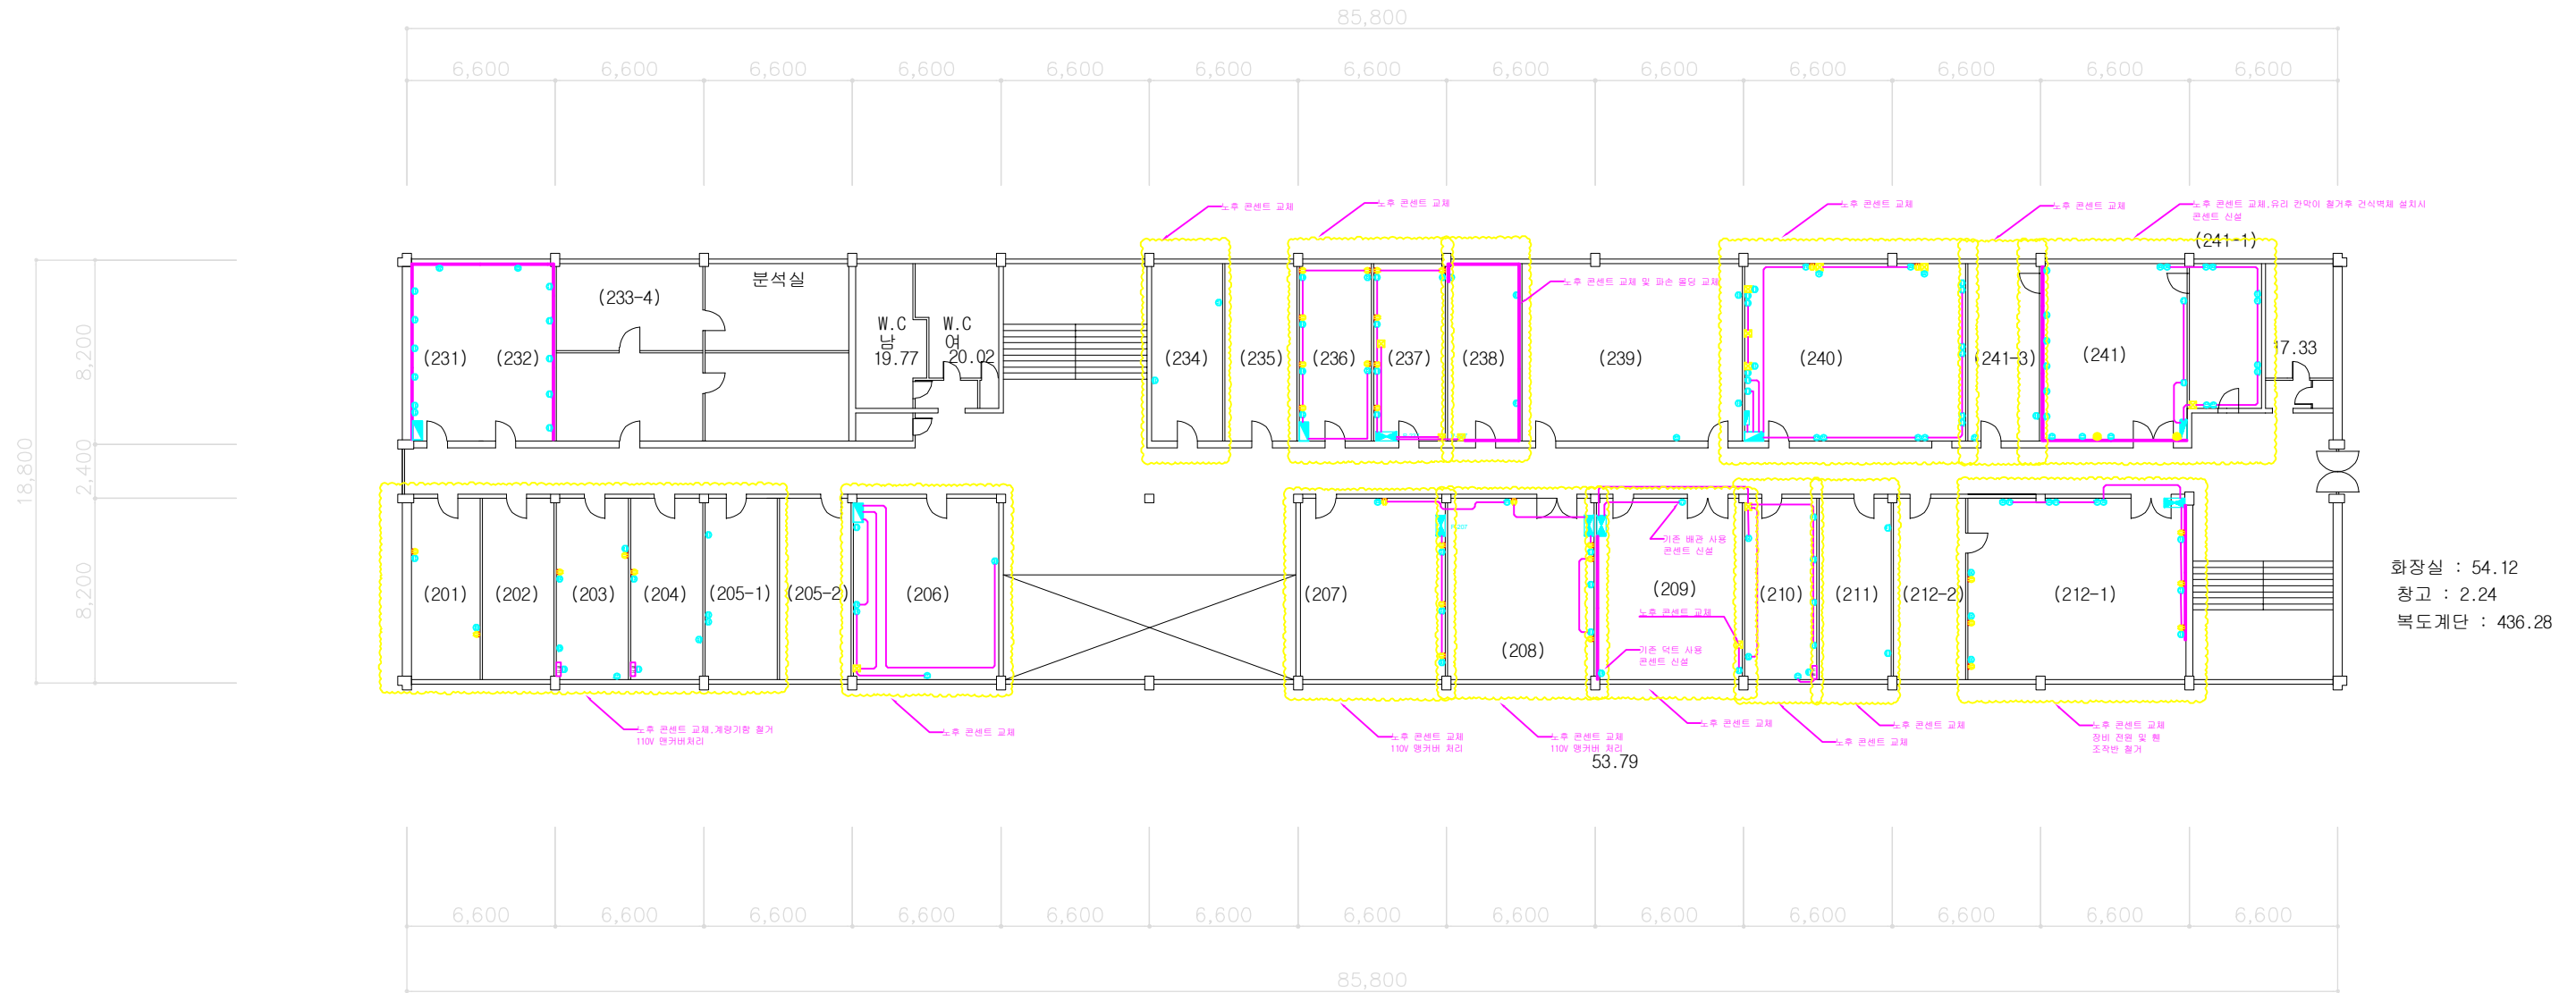

서관 2층 전열 (변경후)

SCALE : 1/300

PROJECT TITLE	
DRAWING TITLE	
APPROVAL	PROJECT NO.
CHECK	FILE NAME
DRAWING	DRAWING NO.
SCALE	
DATE	

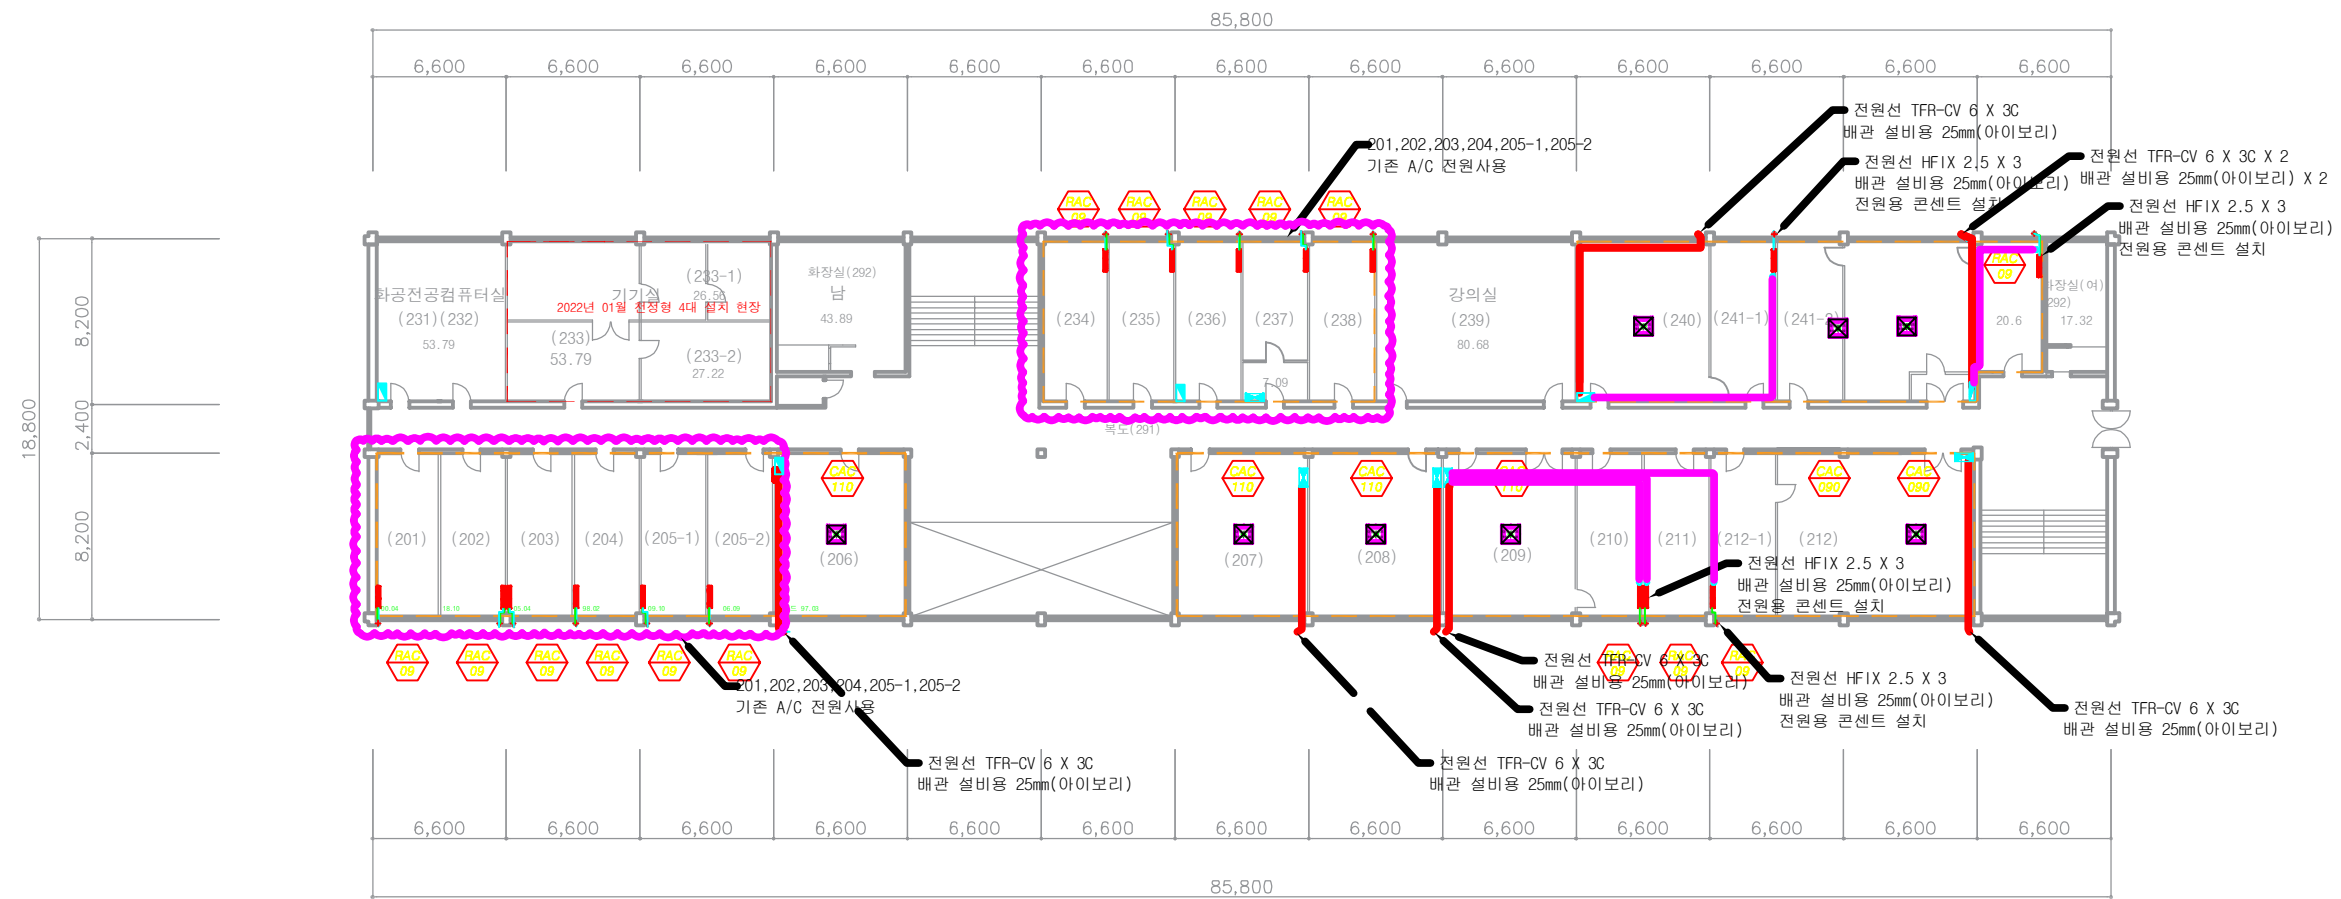

서관 2nd FLOOR PLAN

PROJECT NO.	PROJECT TITLE	DRAWN BY	APPROVED BY	NOTE	REVISION	NAME OF DRAWING			아주대학교
	아주대학교 서관 평면도	CHECKED BY				서관 2층 평면도			
SCALE			DATE	SHEET NO.					